


BID SET
MAY 28, 2010

**ENTREPRENEURSHIP AND
 TECHNOLOGY CENTER**
AT
OHIO UNIVERSITY CHILLICOTHE

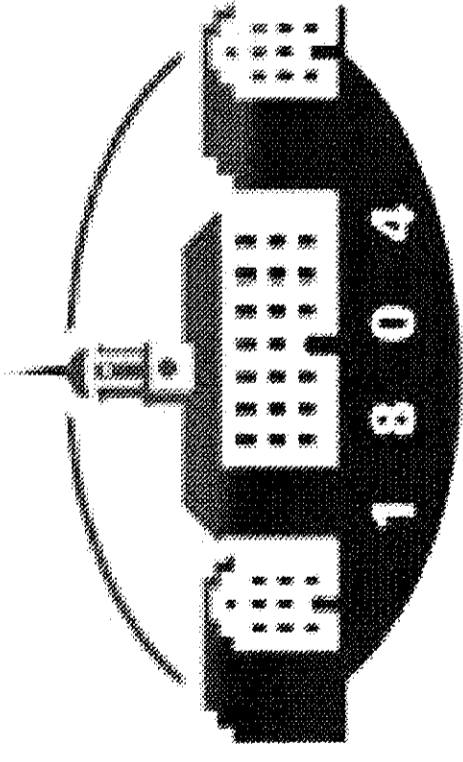

OHIO
 UNIVERSITY

22 SOUTH POHLMAN ROAD
 CHILLICOTHE, OHIO 45601

LEVIN • PORTER • ASSOCIATES • INC
 ARCHITECTURE PLANNING INTERIOR DESIGN
 24 NORTH JEFFERSON STREET
 DAYTON, OHIO 45402-2008
 937 224-1931
 FAX: 937 224-3091
 WEBSITE : WWW.LEVIN-PORTER.COM

M-ENGINEERING, INC.
 MECHANICAL ELECTRICAL PLUMBING CONSULTANTS
 750 BROOKSEDGE BLVD.
 WESTERVILLE, OHIO 43081-2820
 614 839-4639 FAX: 614 839-2222 E-MAIL: ENGINEERING@MENGINEERING.US.COM


INDEX OF DRAWINGS

ARCHITECTURAL AND CIVIL
T-1 TITLE SHEET
T-2 ABBREVIATIONS
T-3 CODE REVIEW
C-1 SITE DEMOLITION PLAN
C-2 FINISHING PLAN AND UTILITY PLAN
C-3 GRADING PLAN
AS-10 SITE DEMOLITION AND NEW WORK PLAN
A-1-0 FLOOR DEMOLITION AND NEW WORK PLAN
A-2-0 ROOFING DEMOLITION PLAN
A-3-0 ROOF TRUSSING AND DETAILS
A-4-0 ELEVATIONS
A-4-1 BUILDING SECTIONS
A-5-0 WALL SECTIONS
A-5-1 WALL SECTIONS
A-5-2 WALL SECTIONS
A-5-3 WALL SECTIONS
A-6-0 ENLARGED PLANS
A-6-1 DOORS
A-6-2 FINISH FLOOR PLAN
AF-1-0
STRUCTURAL
S-1 FOUNDATION PLAN
S-2 ROOF TRUSSING PLAN
S-3 STRUCTURAL NOTES & DETAILS
S-4 WINDOW DETAILS
S-5 FRAMING DETAILS
FIRE SUPPRESSION
FP-1 FIRE PROTECTION PLAN
PLUMBING
PD-1 PLUMBING DEMOLITION PLAN
P-1 PLUMBING PLANS
P-2 SCHEDULES & SCHEMATICS
MECHANICAL
MD-1 HVAC DEMOLITION PLAN & NOTES
M-1 HVAC PLANS
M-2 SCHEDULES & SCHEMATICS
ELECTRICAL
ES-1 ELECTRICAL SITE PLAN
ED-1 ELECTRICAL DEMOLITION PLAN
E-1 ELECTRICAL PLAN & FIXTURE SCHEDULE
E-2 POWER PLAN
E-3 SYSTEMS PLAN
E-4 ELECTRICAL SYMBOLS & RISER DIAGRAM (DEMOL, BASE BID, ALT #1 & ALT #2)

OHIO UNIVERSITY CHILLICOTHE ENTREPRENEURSHIP AND TECHNOLOGY CENTER

BID SET
 28 MAY 2010

SITE LOCATION PLAN

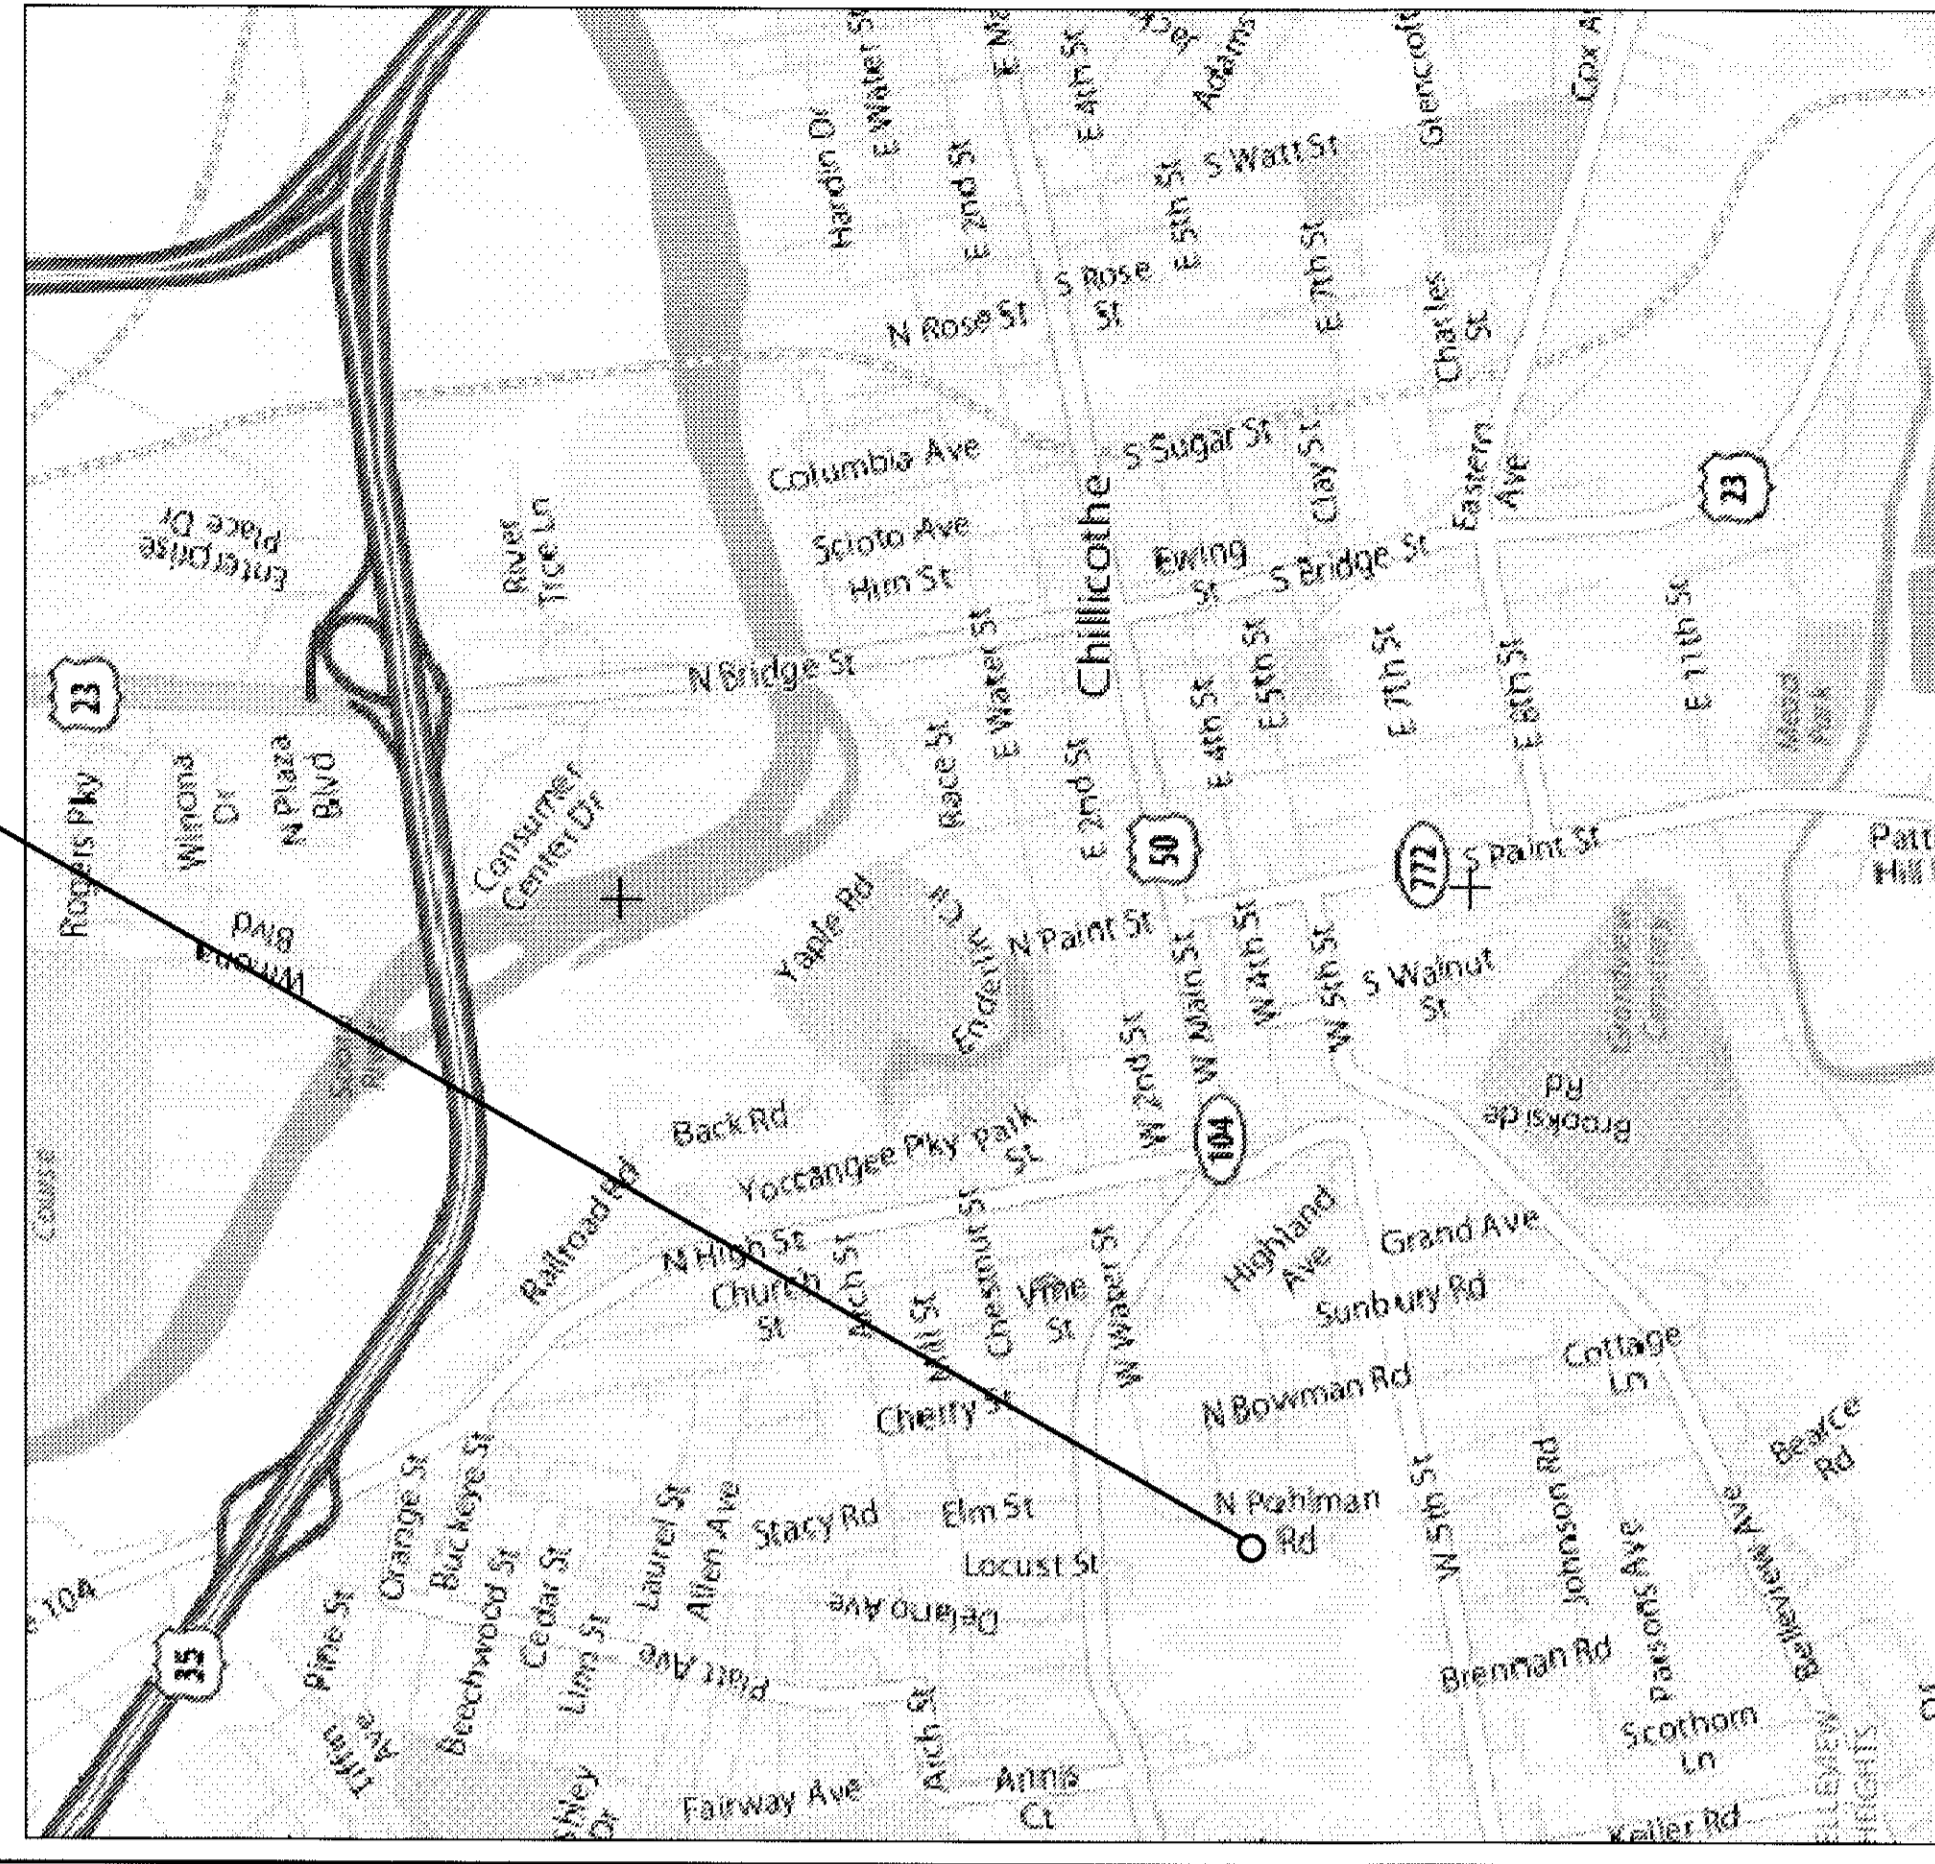

GD REVIEW
 APRIL 21, 2010

LPA PROJECT NO.
 0820100

SET
 NUMBER :

DRAWING NUMBER
 T-1